

KEY PLAN

GENERAL NOTES:

1. ALL DIMENSION ON THIS DRAWING ARE IN MILLIMETERS.
2. ONLY WRITTEN DIMENSIONS ARE TO BE FOLLOWED. DRAWING SHOULD NOT BE SCALED UNDER ANY CIRCUMSTANCES.
3. ALL MEASUREMENTS MUST BE CHECKED AND VERIFIED BY THE CONTRACTORS PRIOR TO EXECUTION OF WORK AT SITE.

CLEINT :

GV RESEARCH CENTERS PVT LTD.
 Plot No.3, Sy.No.230 to 243
 Turkapally, Shamirpet

TECHNICAL ADVISOR
 PRIME CONSULTANT



Koncepto Scientech International Private Limited
 2nd Floor, BNR Towers, 91/A, HP Avenue,
 Electronic city Phase I, Bangalore - 560100
 T: +91-80-61920078
 F: +91-80-61920088
 Email: marketing@koncepto.com
 www.koncepto.com
 | North America | Singapore | China |

ARCHITECT
m | a | r | c | h | i | t | e | c | t | s | p | v | t | . | l | t | d .
 Jaipur - Bangalore - Hyderabad
 Plot No. -1, greenwoods, Lal Kothi Scheme,
 off Sahkar Marg, Jaipur-302001
 Tel: 91 141 4299999,
 email - studio@maarchitects.in web-www.maarchitects.in

STRUCTURAL CONSULTANT
Dixcons, Consulting Engineers
 #7 GF, Rohini Enclave, 14th main, 1st cross
 Ultrahalli Main Road, Bangalore-61.
 Ph:26395244

MEP CONSULTANT

REV.	DATE	DESCRIPTION

00 | 21.01.2019 | Good For Construction

PROJECT :


GVRC

DRAWING TITLE : FLOOR PLANS
 BUILDING - 6500 (PIONEER MODULE)

PROJ. NO: 061 | DATE: 21.01.2019
 DRAWING NO: KSI-GVRC-CS-AR-008-Rev 00

A01 | SCALE: 1 : 150 | SHEET NO: 01 OF 01

LAB PLANNER: SHIVA | PREPARED BY: RAMEEZ | CHECKED BY: SRIKAR | APPROVED BY: JAY

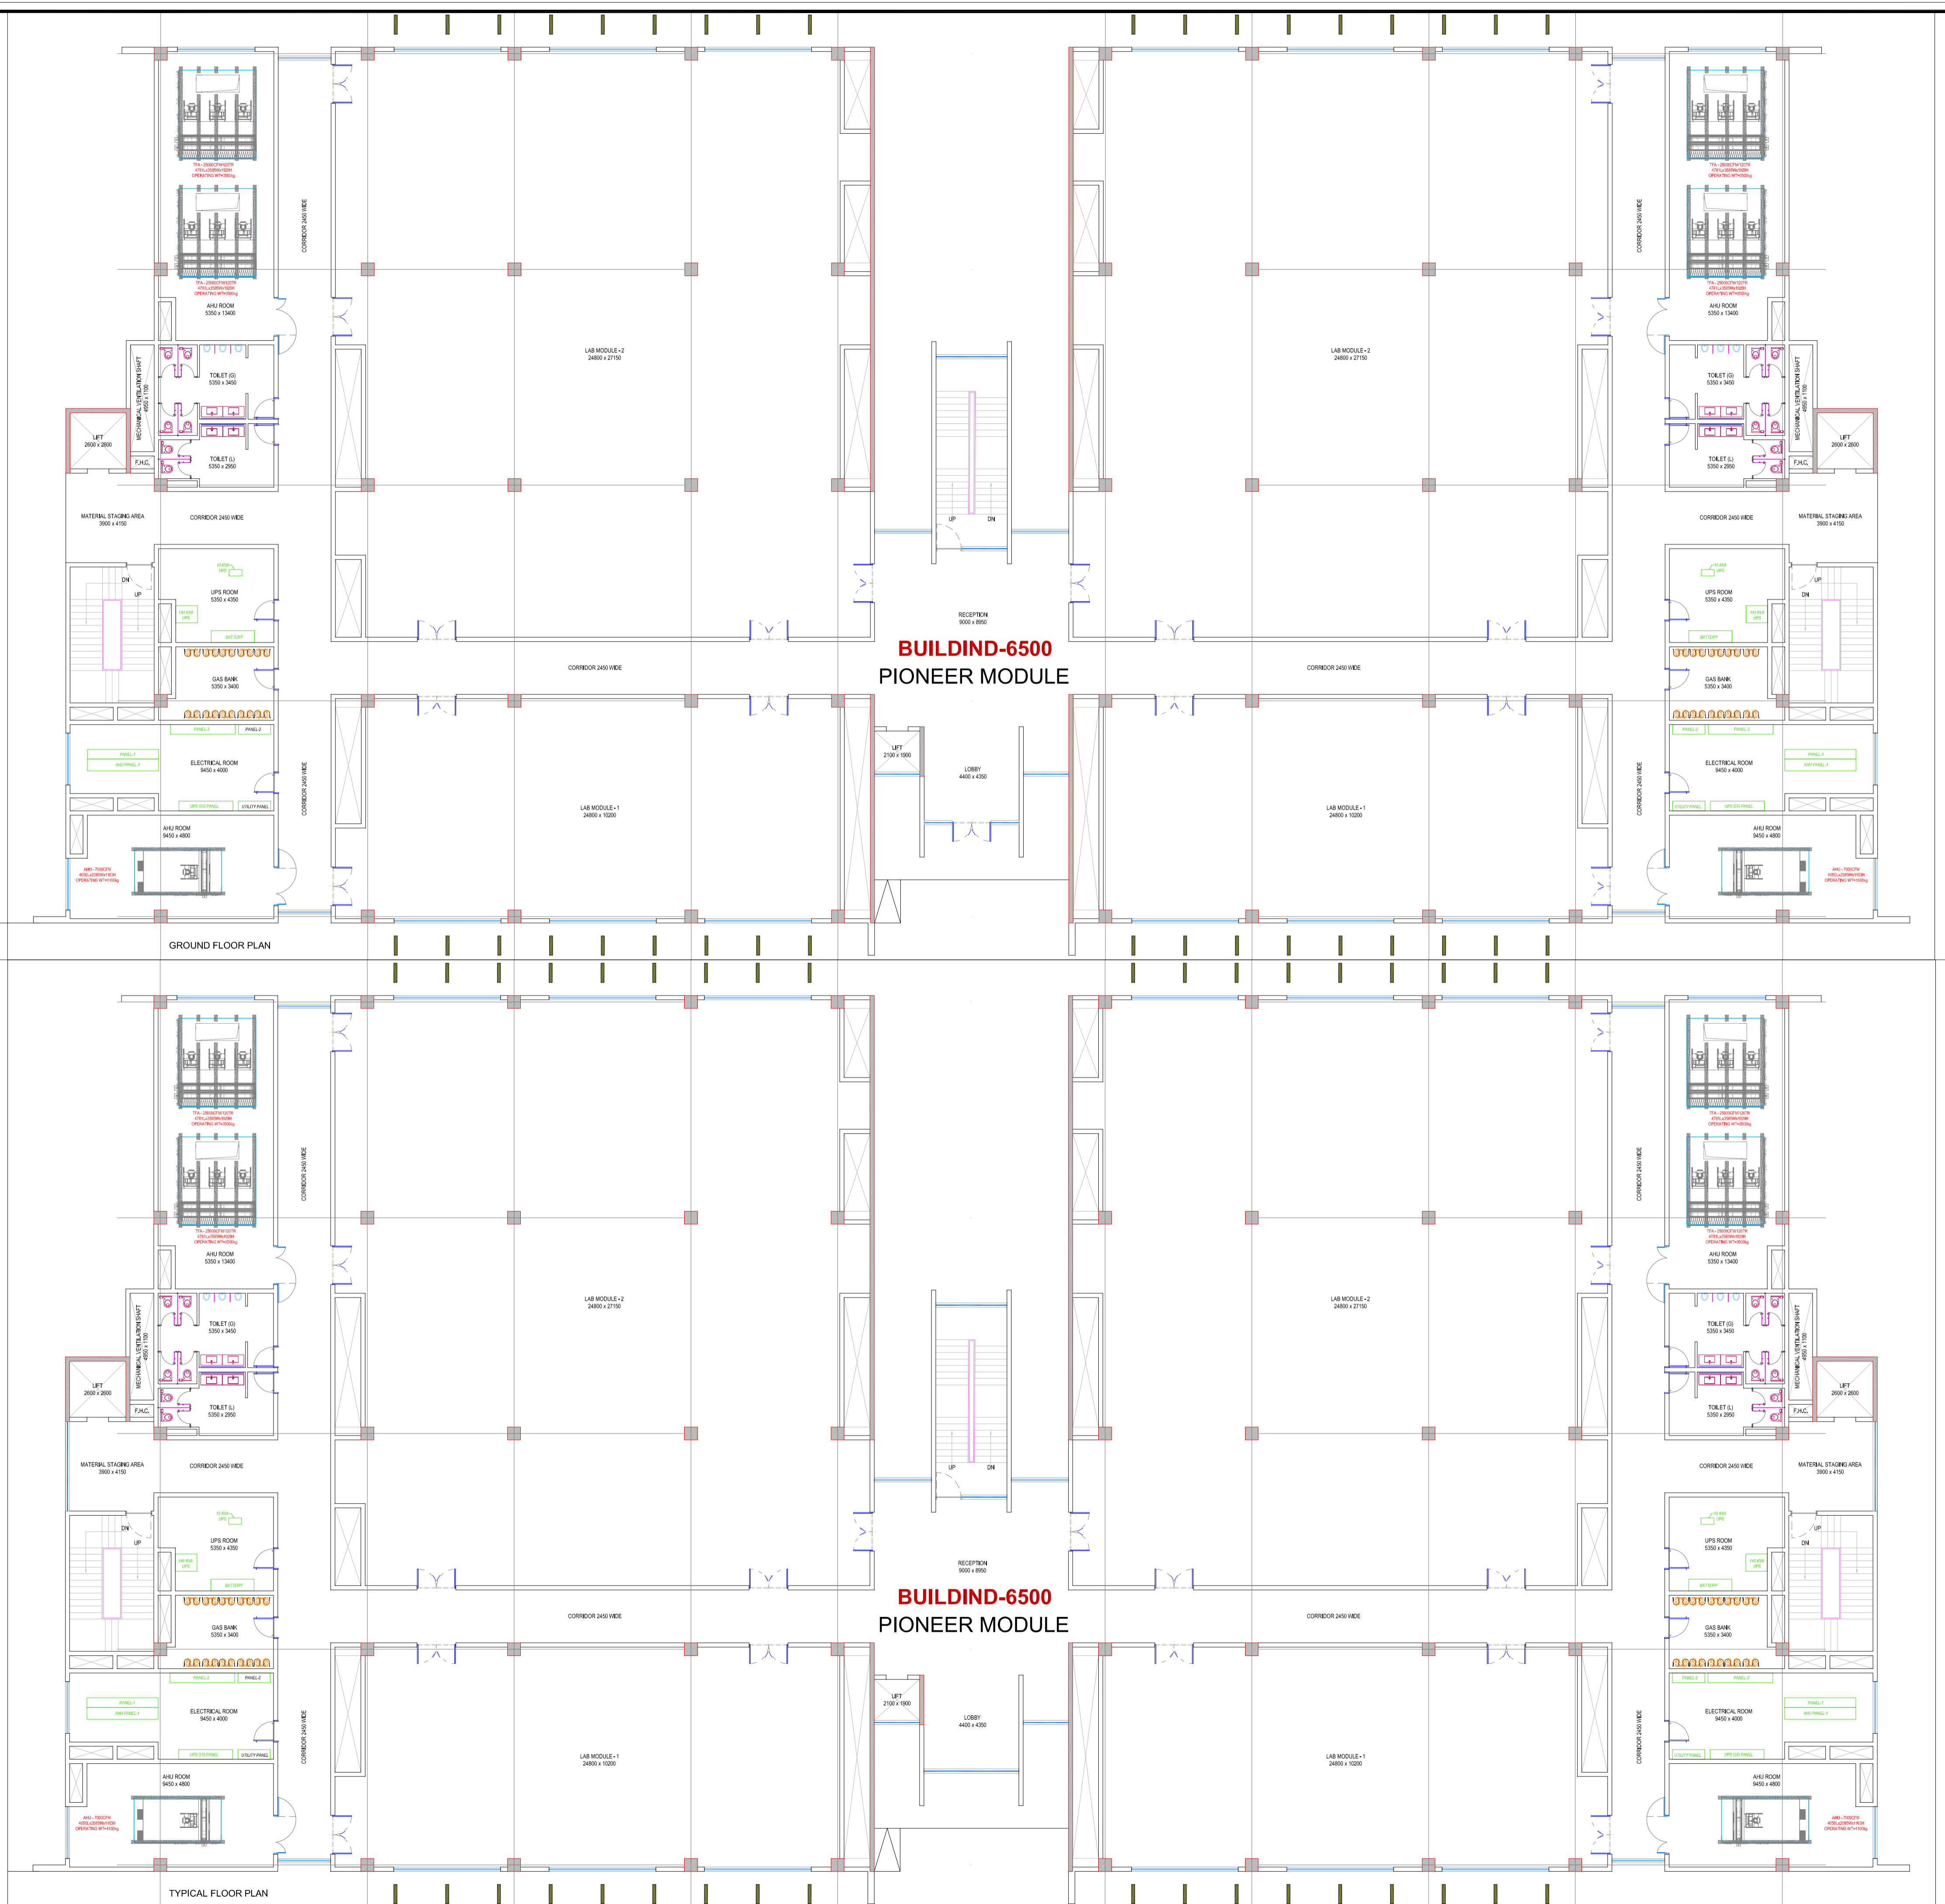

BUILDIND-6500
PIONEER MODULE

BUILDIND-6500
PIONEER MODULE