

**GENERAL NOTES:**  
 1. ALL DIMENSIONS ARE IN METERS UNLESS SPECIFIED OTHERWISE.  
 2. ALL WORK IS TO BE DONE AS PER THE SPECIFICATIONS AND DRAWINGS.  
 3. THE CONTRACTOR SHALL BE RESPONSIBLE FOR OBTAINING ALL NECESSARY PERMITS AND APPROVALS FROM THE LOCAL AUTHORITIES.  
 4. THE CONTRACTOR SHALL MAINTAIN ACCESS TO ALL ADJACENT PROPERTIES AT ALL TIMES.


**CLIENT:**  
 GV RESEARCH CENTERS PVT LTD,  
 Plot No. 3, By No. 256 to 245,  
 Turinagar, Shantapur

**TECHNICAL ADDRESS:**  
 PRIME CONSULTANTS & MEP CONSULTANT


**Koncepto**  
 Koncepto Scientific International Private Limited  
 2nd Floor, 8th Cross, 8th St, 8th Avenue,  
 Electronic City Phase 1, Bangalore - 560100  
 T: +91-80-45020000  
 F: +91-80-45020001  
 Email: info@koncepto.com  
 www.koncepto.com  
 8, 9th Avenue, 8, 9th Cross, 8th Avenue, 8th Cross

**ARCHITECT:**  
 m | a | r | c | h | i | t | e | c | t | s | p | v | t | l | t | d.  
 47/2F, 8th Cross, 8th Avenue, 8th Avenue,  
 Electronic City Phase 1, Bangalore - 560100  
 T: +91-80-45020000  
 F: +91-80-45020001  
 Email: info@marcths.com  
 www.marcths.com


**STRUCTURAL CONSULTANT:**  
 D | H | G | O | M | S | C | o | n | s | u | l | t | i | n | g | E | n | g | i | n | e | e | r | s  
 47/2F, 8th Cross, 8th Avenue, 8th Avenue,  
 Electronic City Phase 1, Bangalore - 560100  
 T: +91-80-45020000  
 F: +91-80-45020001  
 Email: info@dhgoms.com  
 www.dhgoms.com

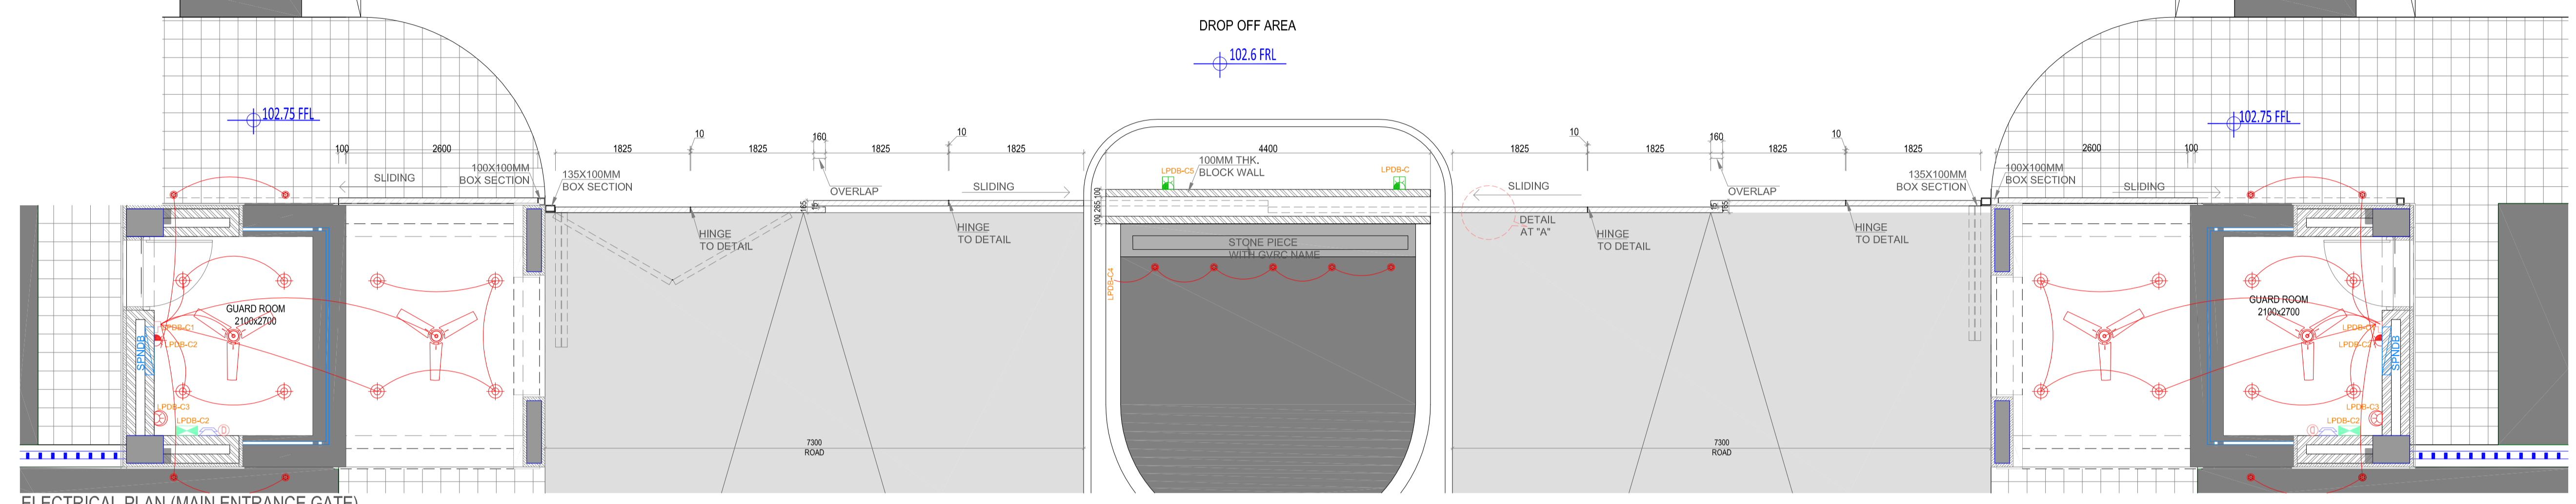


ELECTRICAL PLAN (MAIN ENTRANCE GATE)  
 SCALE- 1: 25

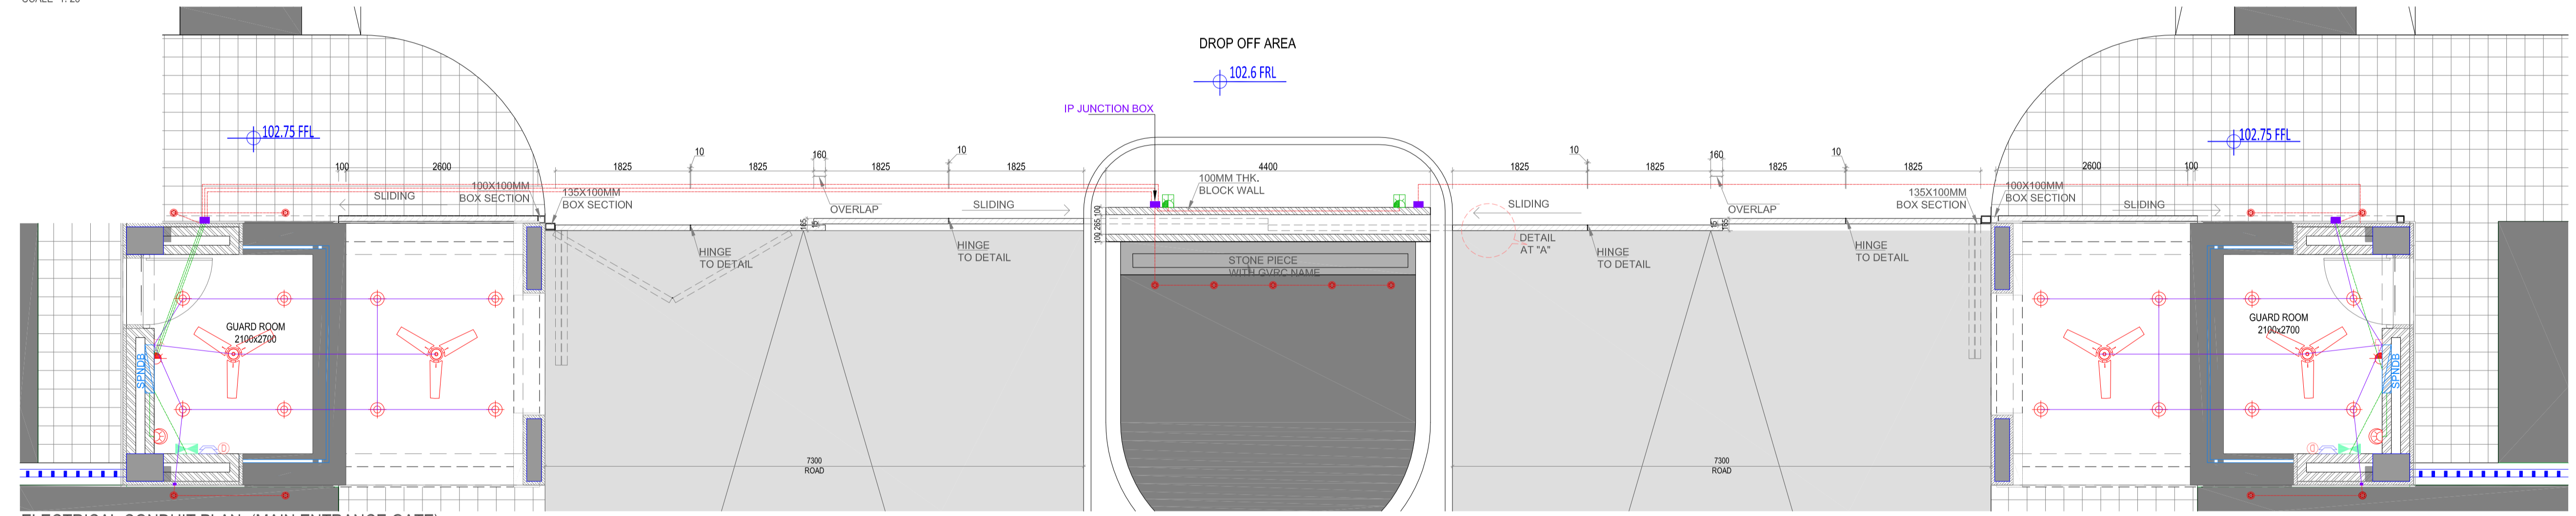

ELECTRICAL CONDUIT PLAN (MAIN ENTRANCE GATE)  
 SCALE- 1: 25

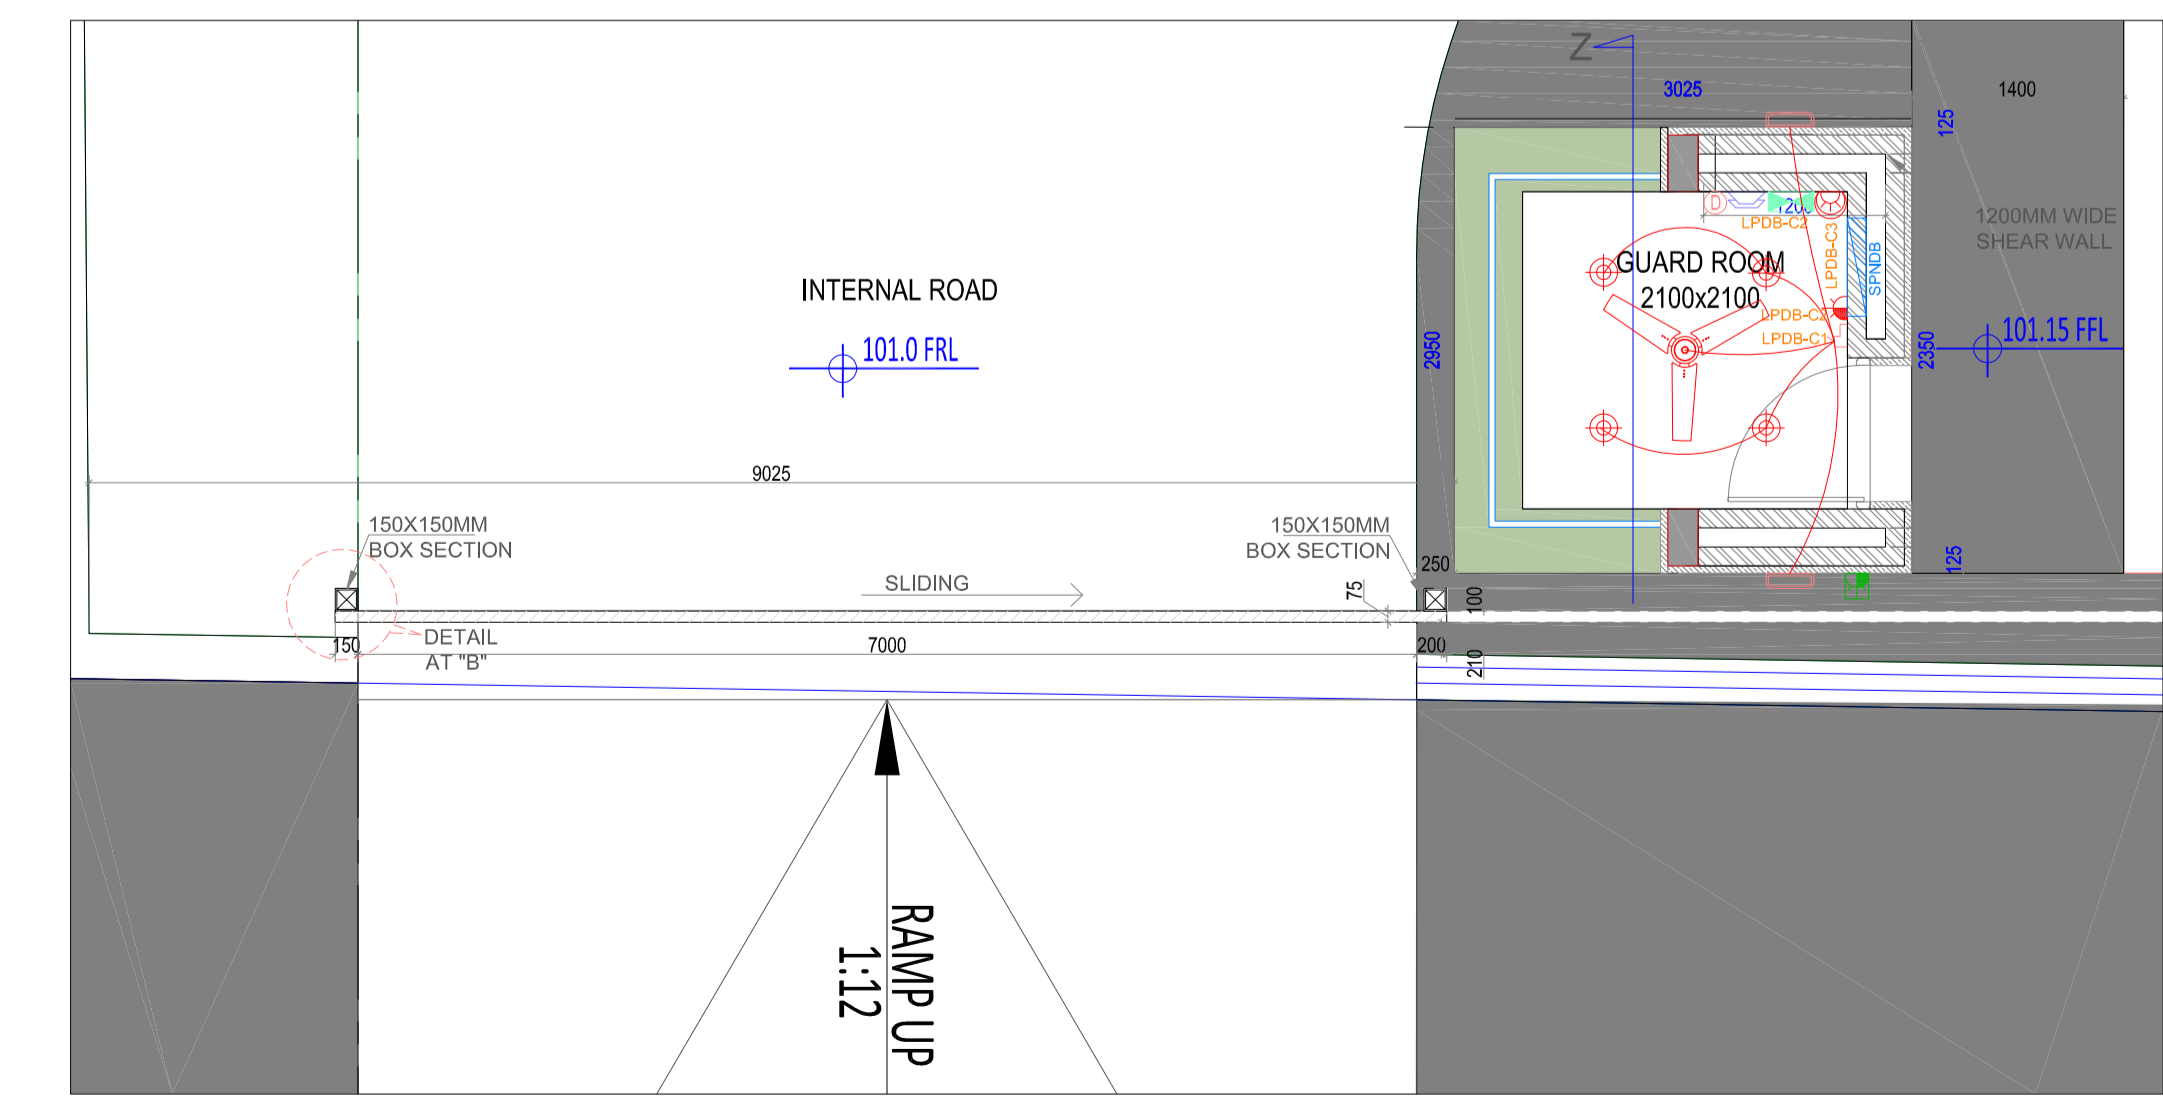

ELECTRICAL PLAN -2 (MATERIAL ENTRY GATE)  
 SCALE- 1: 25

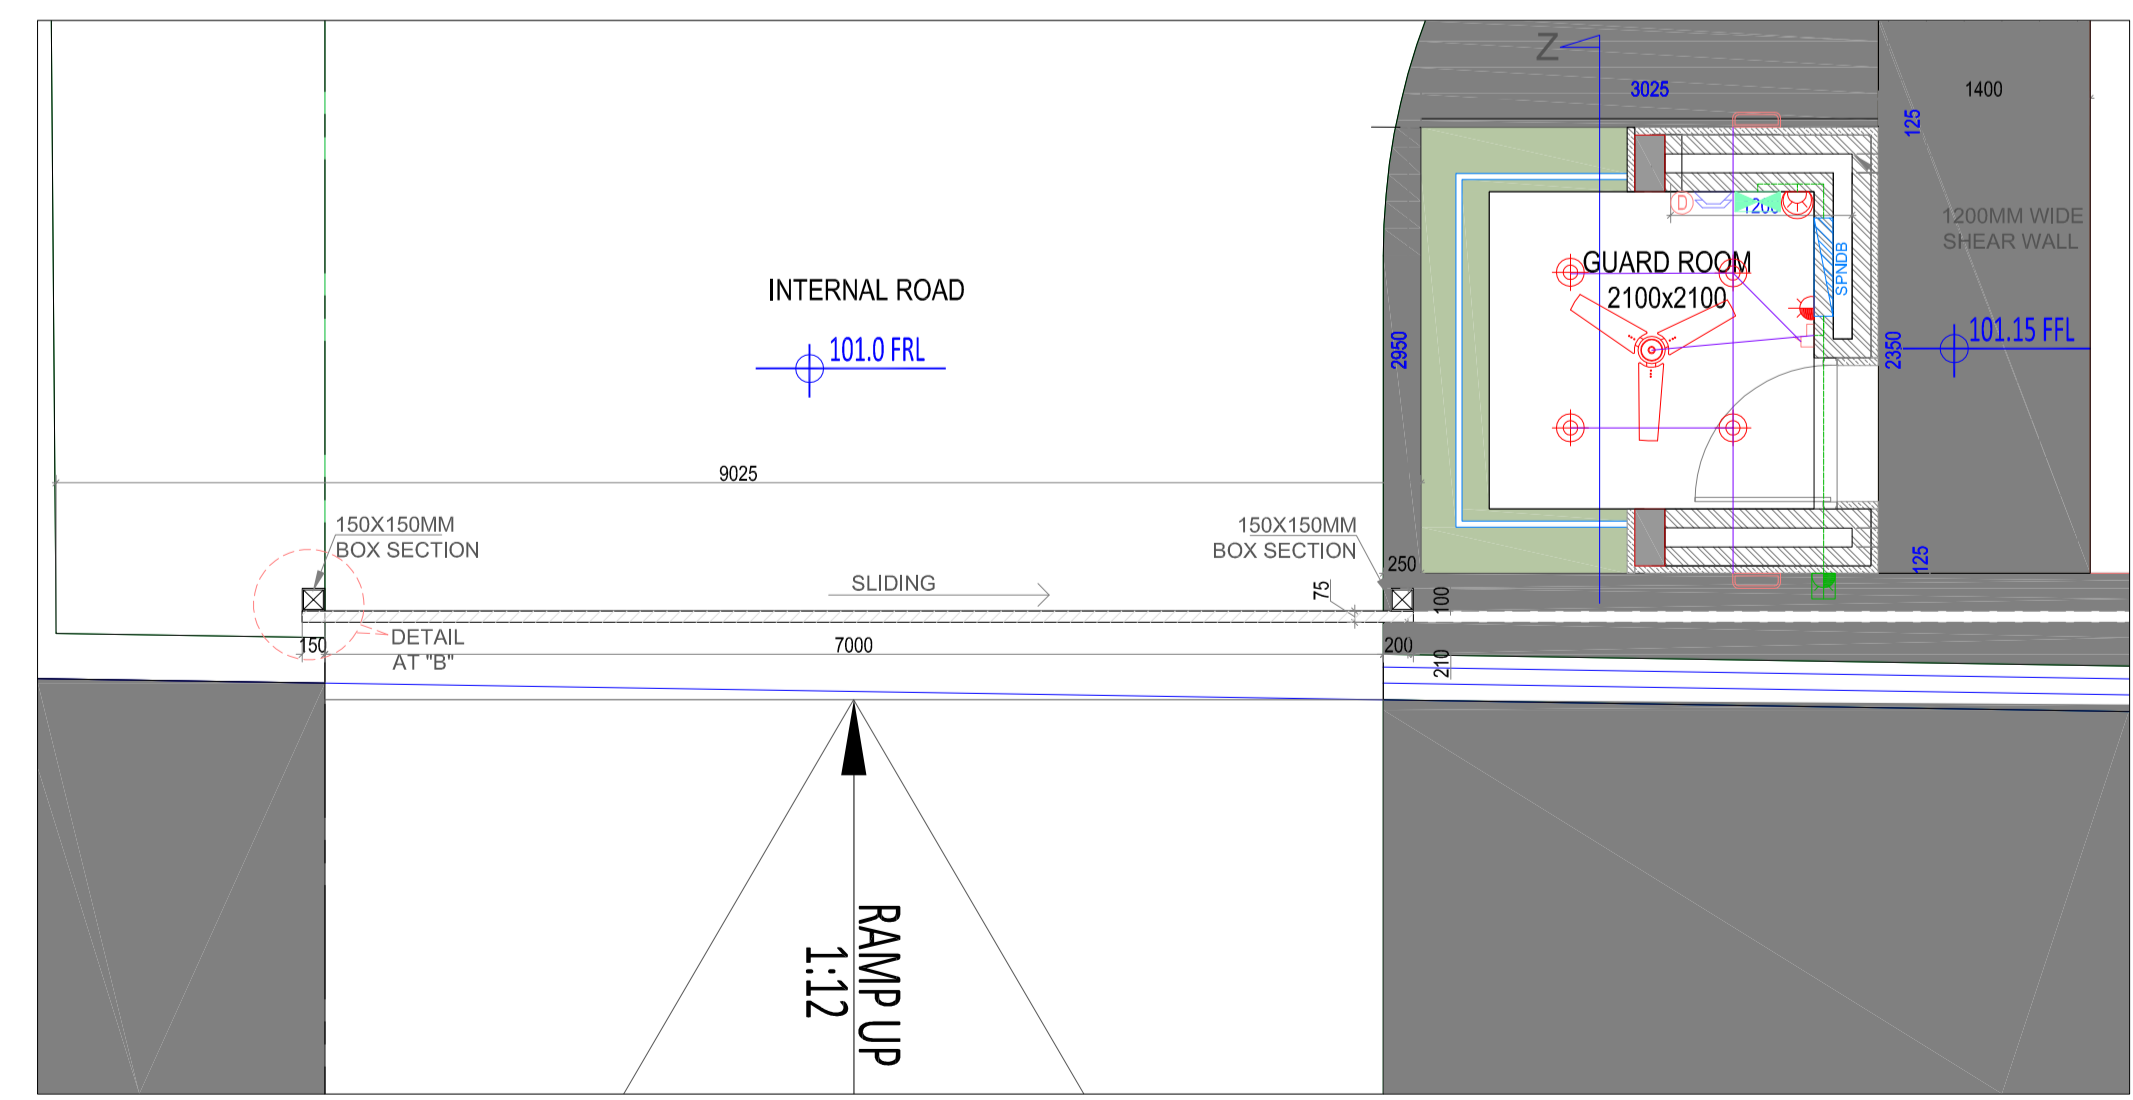

ELECTRICAL CONDUIT PLAN -2 (MATERIAL ENTRY GATE)  
 SCALE- 1: 25

**LEGEND :-**

SYMBOL	DESCRIPTION
	DOWNLIGHT FIXTURE
	BURIAL LIGHT FIXTURE
	3X6/10A UPS POWER SOCKET
	1X6/16A GENERAL RAW POWER SOCKET@FLOOR
	AC SOCKET RAW POWER SOCKET@ CEILING
	VOICE POINT
	DATA POINT
	SWITCH BOARD FFL @ 1200mm
	GENERAL LIGHT WIRING
	DISTRIBUTION BOARD
	LIGHTING CONDUIT
	POWER CONDUIT
	FLOOR CONDUIT
	SOCKET FOR GATE MECHANICAL OPERATION
	IP 65 ELECTRICAL JUNCTION BOX'S
	FAN POINT

REV.	DATE	DESCRIPTION
01	13.04.2019	ISSUED AS PER CLIENT COMMENTS
02	10.04.2019	PRELIMINARY LAYOUT

PROJECT: GVRC

DRAWING TITLE: ENTRANCE GATE ELECTRICAL DETAIL  
 PROJ. NO.: DATE: 10.04.2019  
 DRAWING NO.: KSB-GVRC-4E-LAC LV-001

SCALE	SHEET NO.	OF TOTAL
1:25	01	01

PROGRAMMED / PREPARED BY: [Name]  
 CHECKED BY: [Name]  
 APPROVED BY: [Name]