

PROJECT
VISTA HOMES
MODEL FLAT

CLIENT
MODI PROPERTIES
M.G.ROAD,


TITLE
INTERIOR DRAWING
ELECTRICAL CHANGES

S.N	DATE	S.N	DATE

DRAWING DETAILS
2BHK-WEST FACING
MODEL FLAT-TYPE C-103
FALSE CEILING DESIGN


Scale:	
Drawn by:	AM
Checked by:	AR
Date:	10-10-13
Drawing Codes:	
Sheet No.:	01 OF 04
INTERIOR CONSULTANTS:	

ARDES
ARCHITECTS & INTERIOR DESIGNERS
7-1-2128NIV-ANAGH, AMBERPET, HYDERABAD,
040-25773331 & email: modidev@arades.com

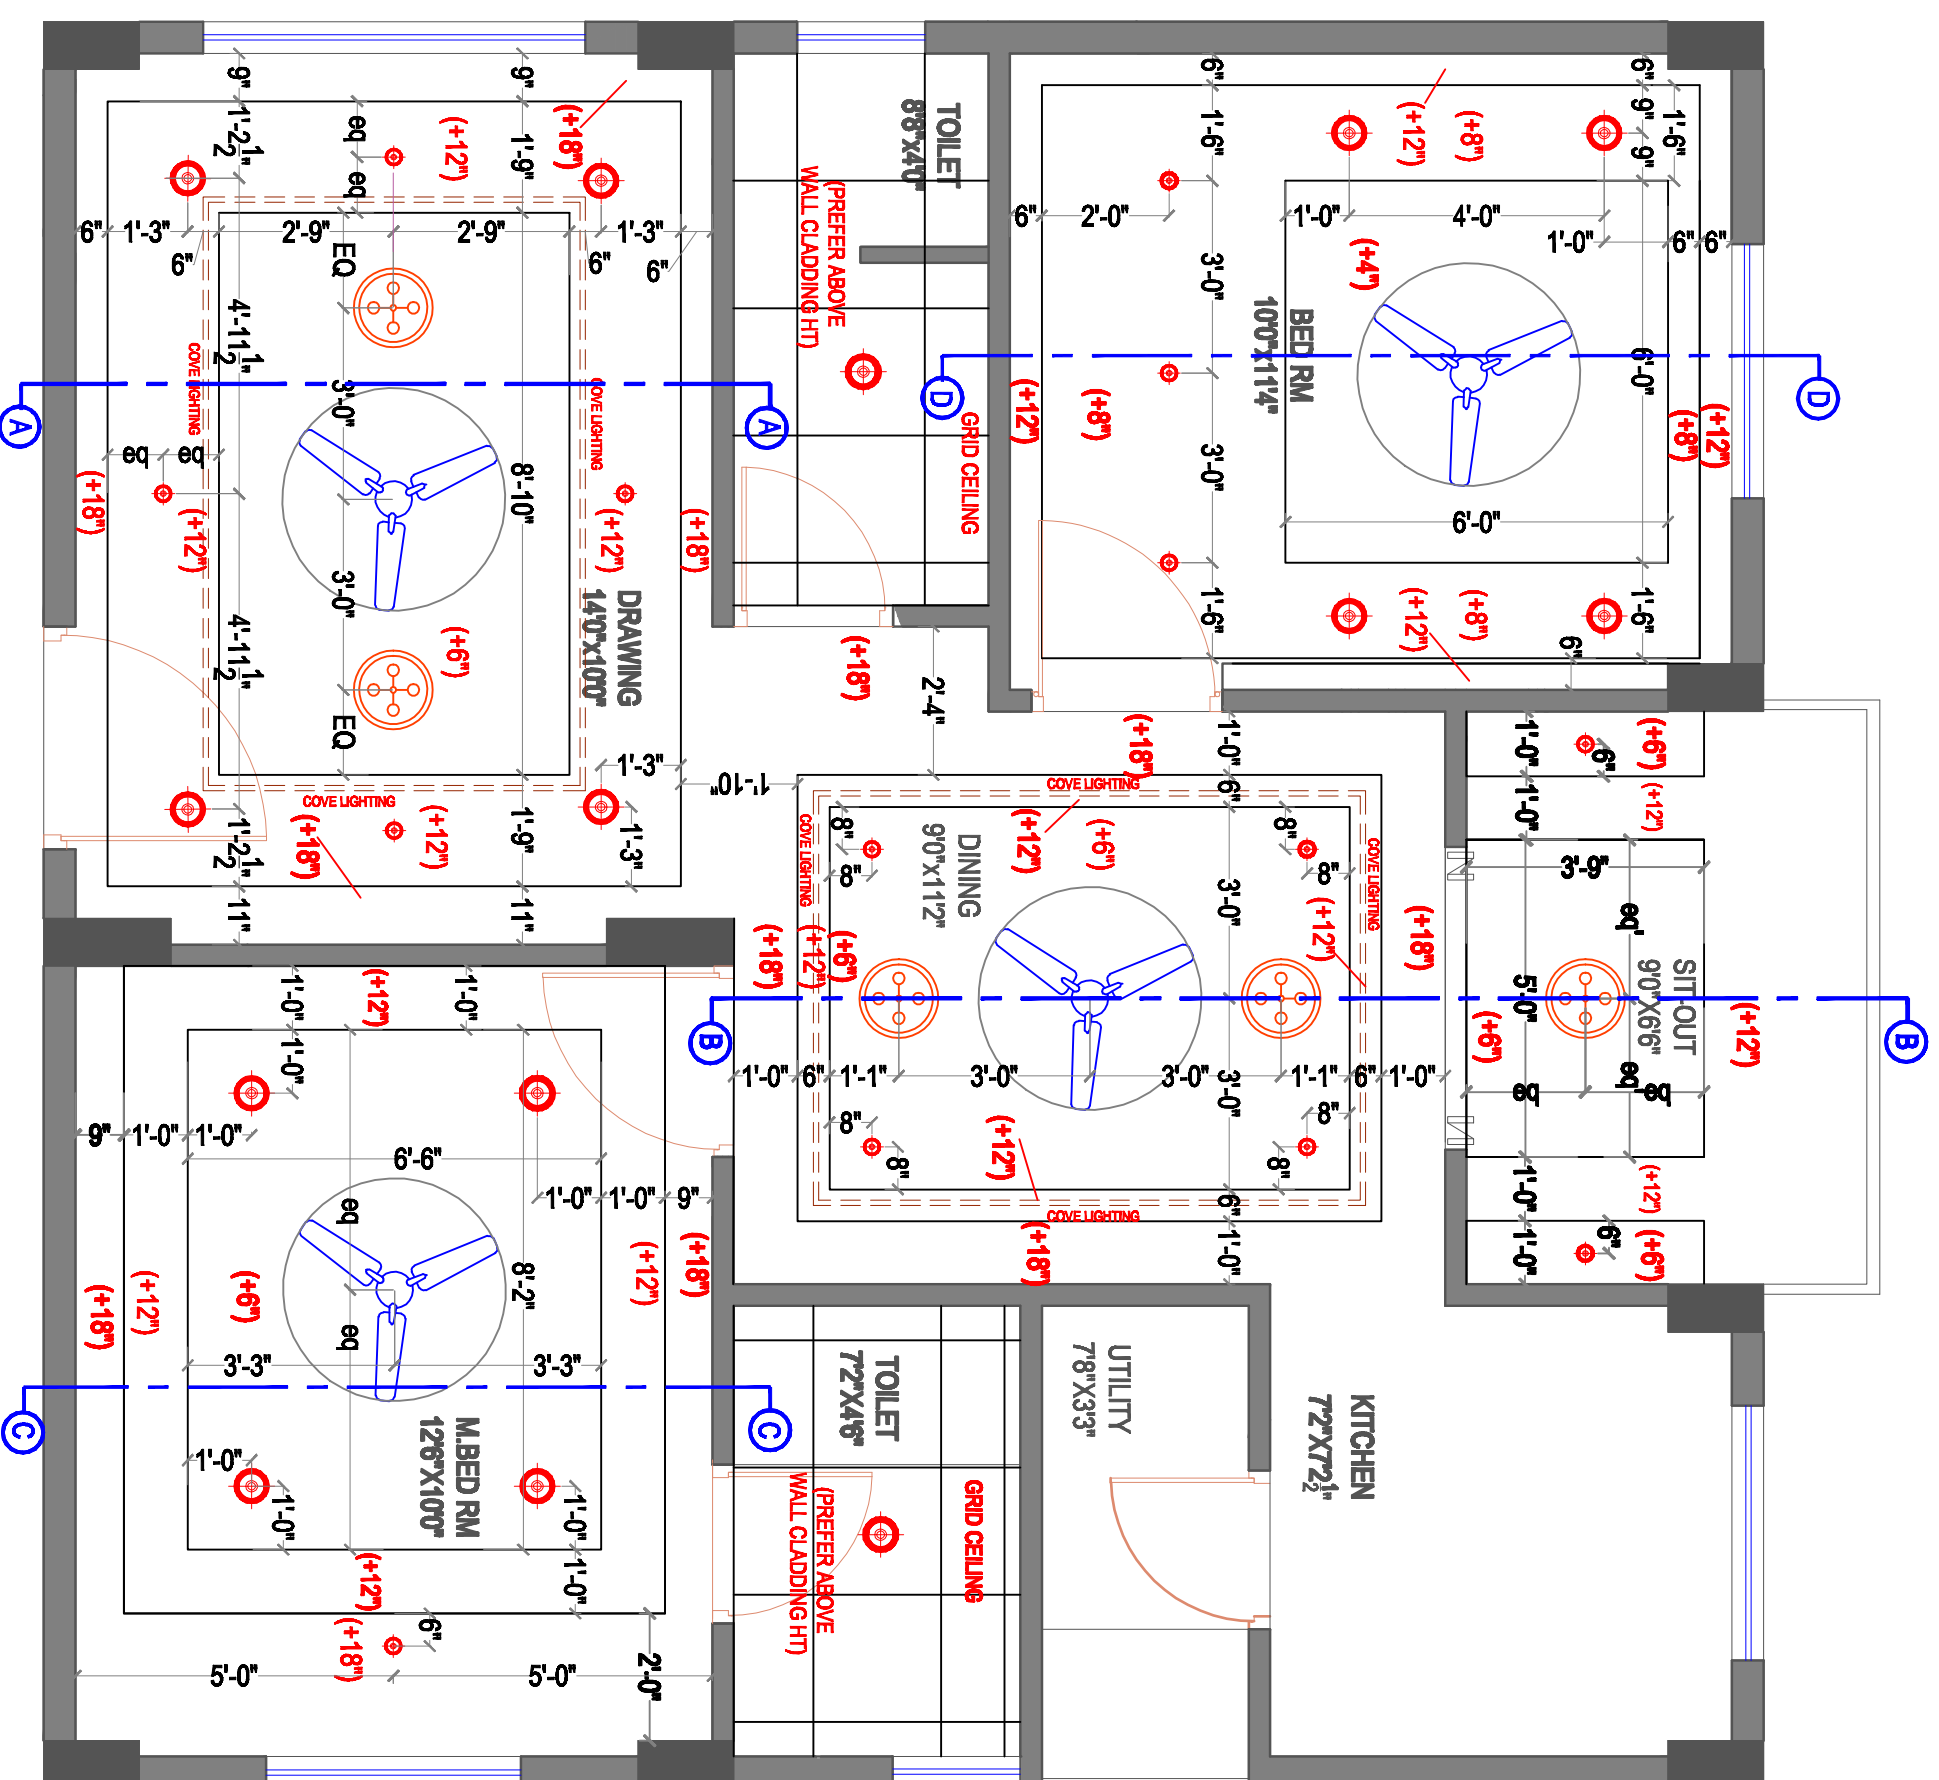


ELECTRICAL LEGEND

SYMBOL	DESCRIPTION	MOUNTING HT.
	down lighter(2x18w)	ceiling ht
	3W LED spot light	ceiling
	HANGING LIGHT	ceiling ht
	ceiling fan	ceiling ht
	cove light	as indicated

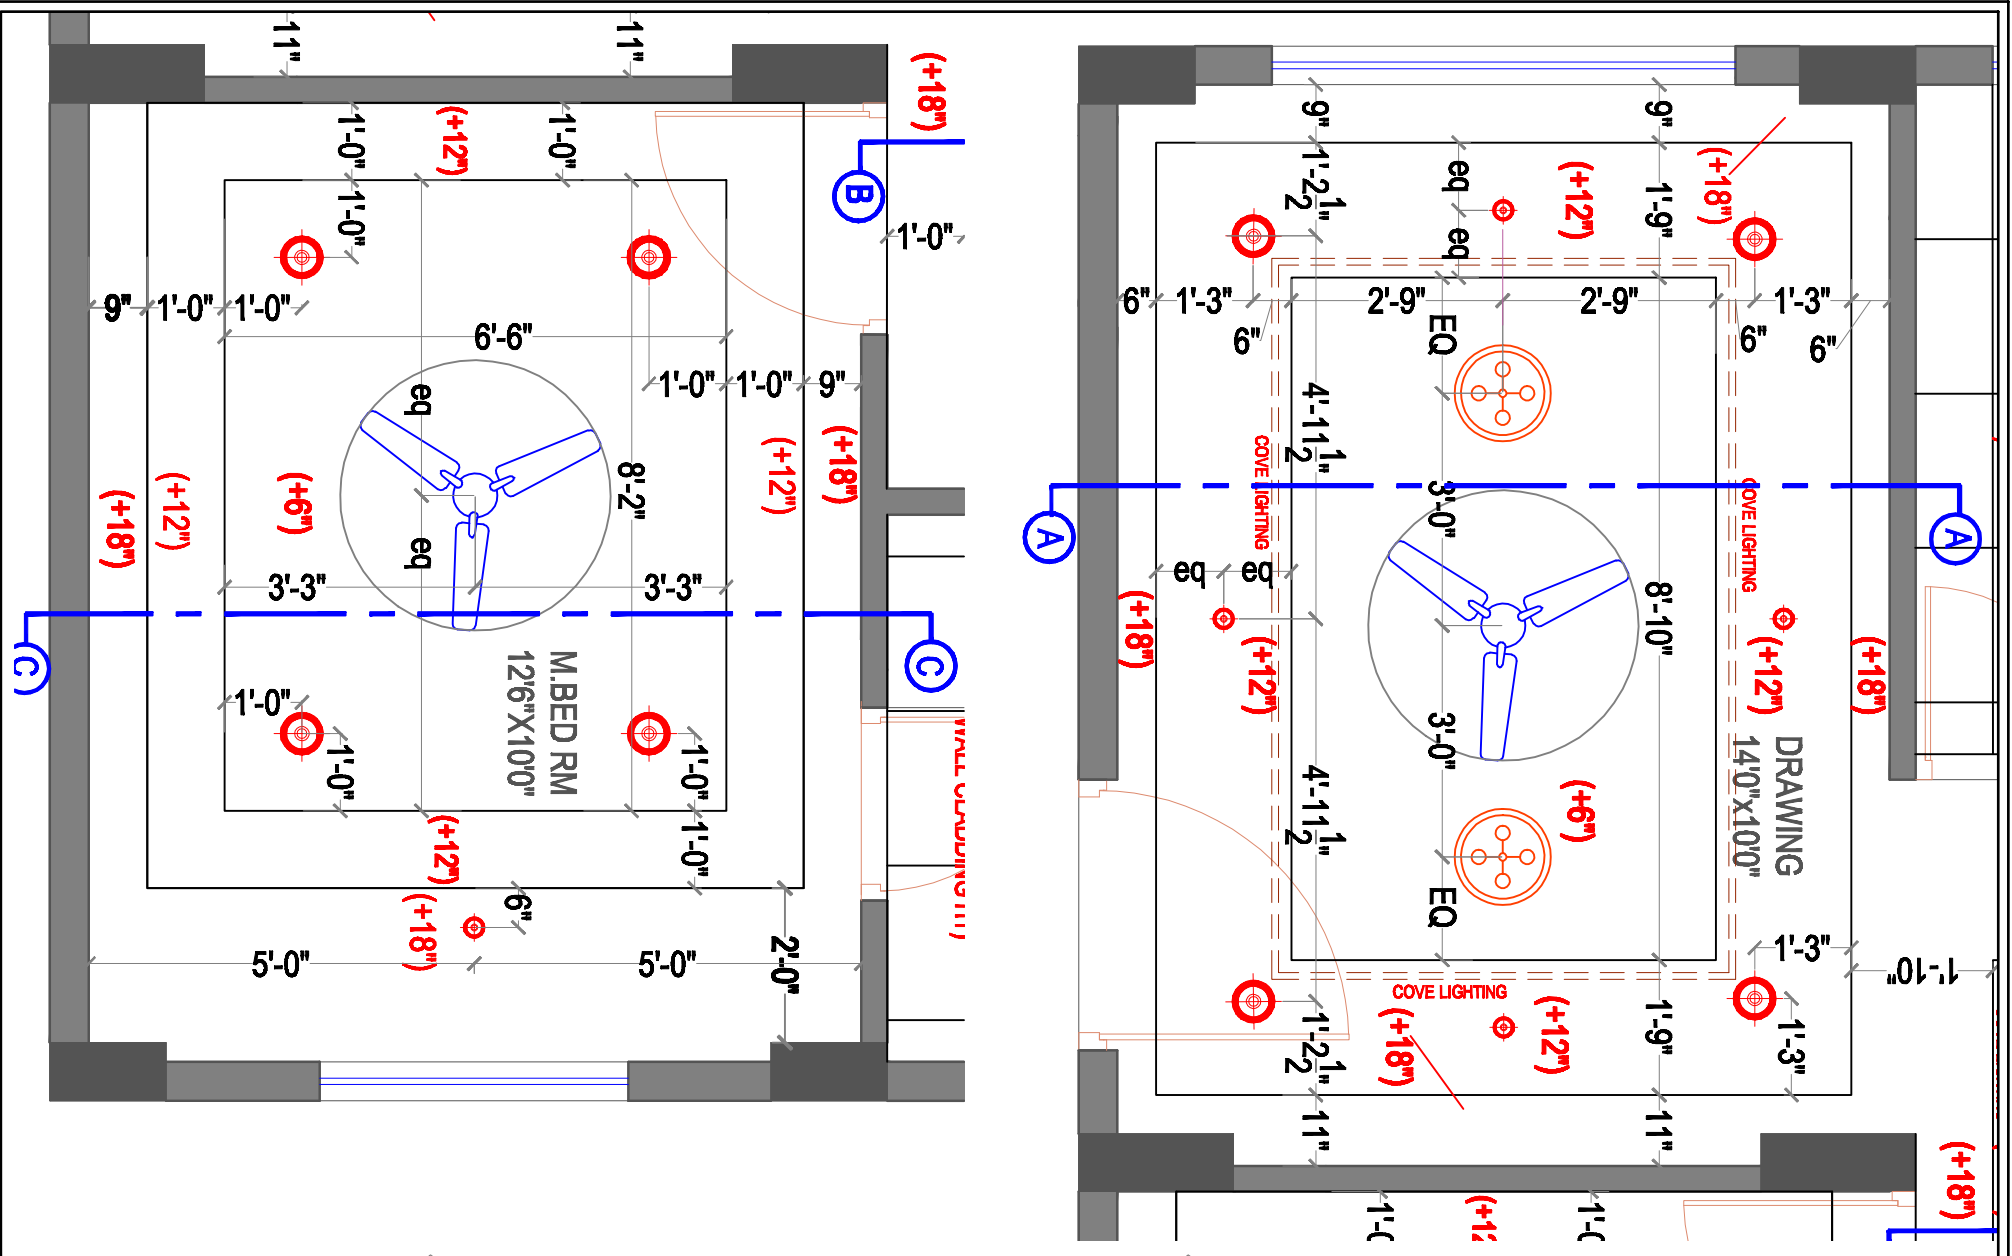


DRAWING LAYOUT


MASTER BEDROOM LAYOUT

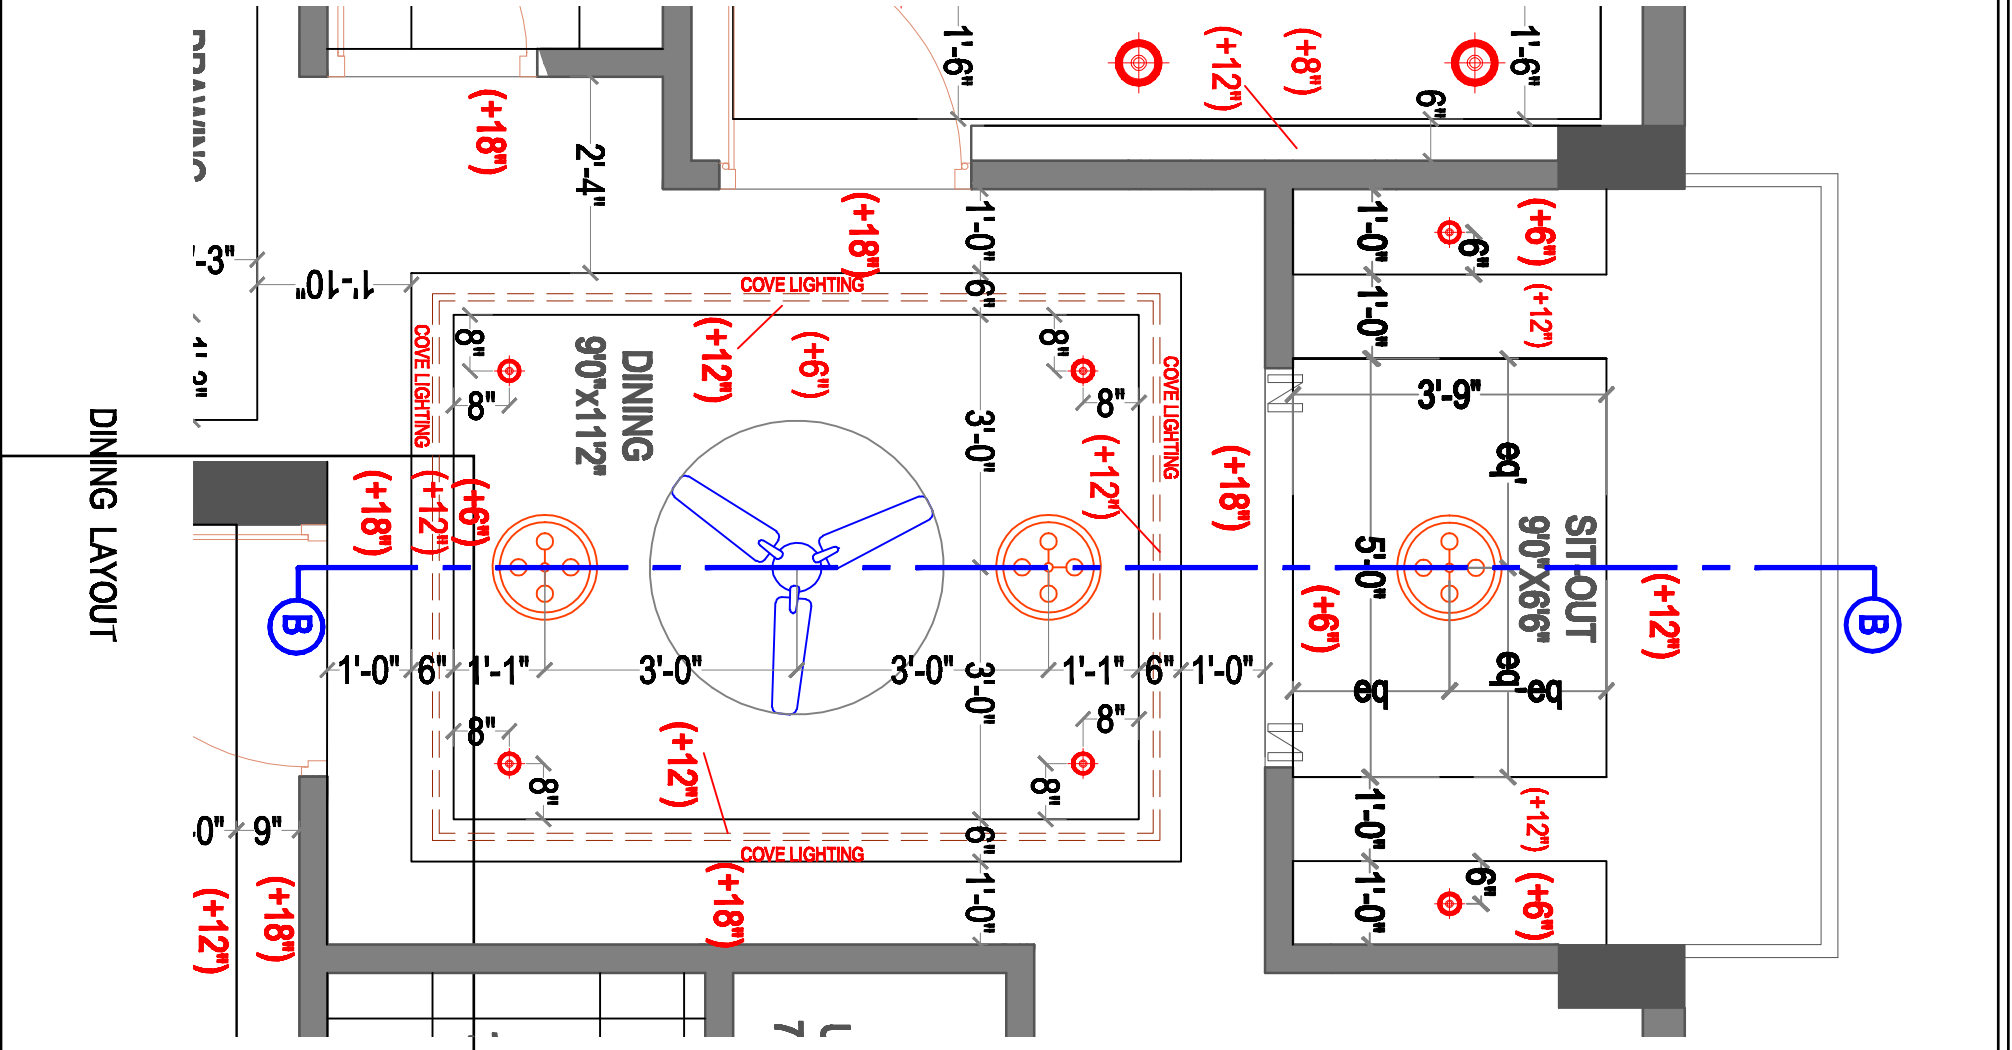

DRAWING LAYOUT

DINING LAYOUT

PROJECT		VISTA HOMES	
MODEL FLAT			
CLIENT		MODI PROPERTIES	
M.G.ROAD,			
TITLE		INTERIOR DRAWING	
ELECTRICAL CHANGES			
S.N	DATE	S.N	DATE
DRAWING DETAILS			
2BHK-WEST FACING			
MODEL FLAT-TYPE C-103			
FALSE CEILING DESIGN			
Scale:			
Drawn by:	AM		
Checked by:	AR		
Date:	10-10-13		
Drawing Codes:			
Sheet No.:	2 OF 4		
INTERIOR CONSULTANTS:			
 ARDES ARCHITECTS & INTERIOR DESIGNERS 7-1-2128NIV-SANGLI, AMBERPET, HYDERABAD, 040-28773331 & email: modidev@modi.com			

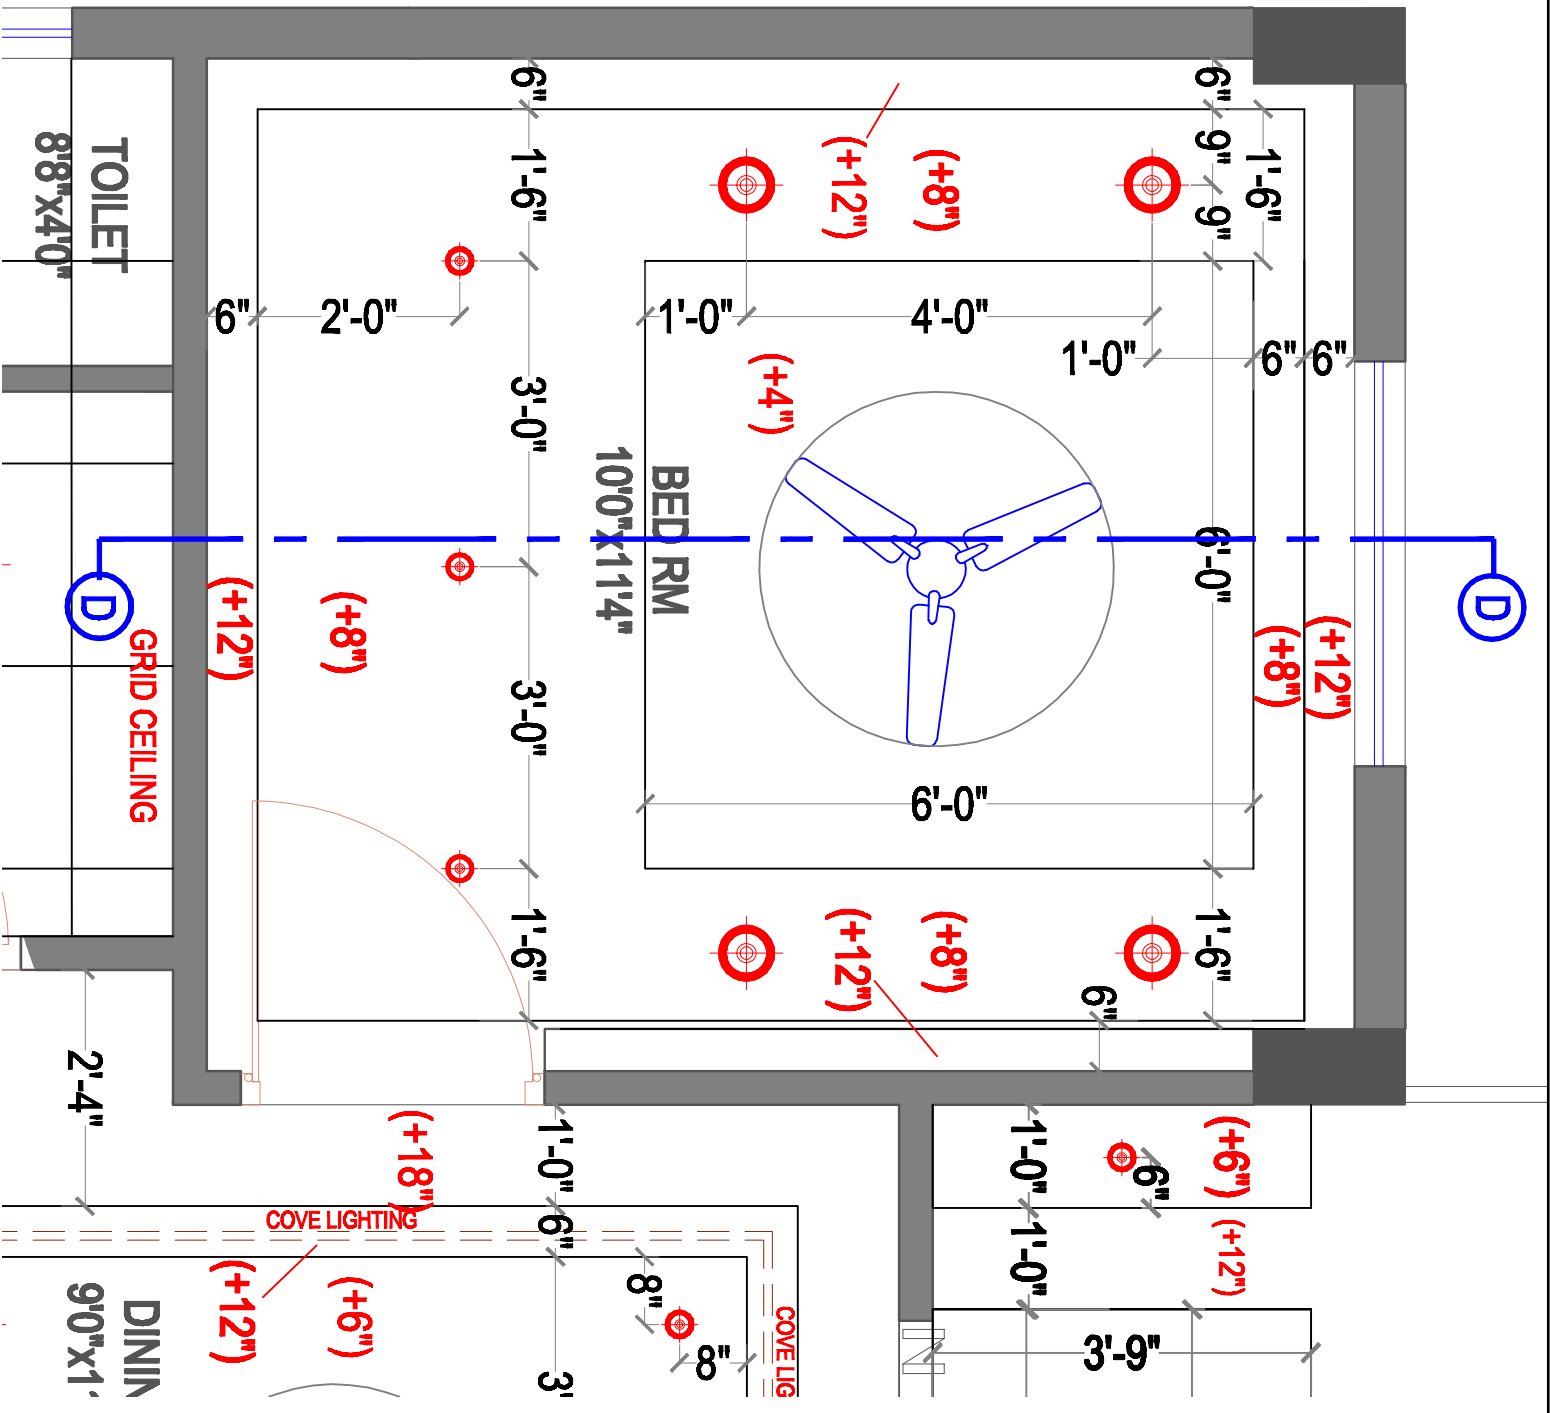


**GUEST
BEDROOM
LAYOUT**


ELECTRICAL LEGEND

SYMBOL	DESCRIPTION	MOUNTING HT.
	down lighter(2x18w)	ceiling ht
	3W LED spot light	ceiling
	HANGING LIGHT	ceiling ht
	ceiling fan	ceiling ht
	cove light	as indicated


PROJECT	VISTA HOMES		
MODEL FLAT	MODEL FLAT		
CLIENT	MODI PROPERTIES		
M.G.ROAD,			
TITLE	INTERIOR DRAWING		
ELECTRICAL CHANGES			
S.NG	DATE	S.NG	DATE
DRAWING DETAILS			
2BHK-WEST FACING			
MODEL FLAT-TYPE C-103			
FALSE CEILING DESIGN			
Scale:			
Drawn by:	AM		
Checked by:	AR		
Date:	10-10-13		
Drawing Codes:			
Sheet No.:	SHEET 3 OF 4		
INTERIOR CONSULTANTS:			
ARDES	ARCHITECTS & INTERIOR DESIGNERS		
	7-1-21284V-3A-04, AMBERPET, HYDERABAD,		
	040-2873331 & email: modidesign@gmail.com		

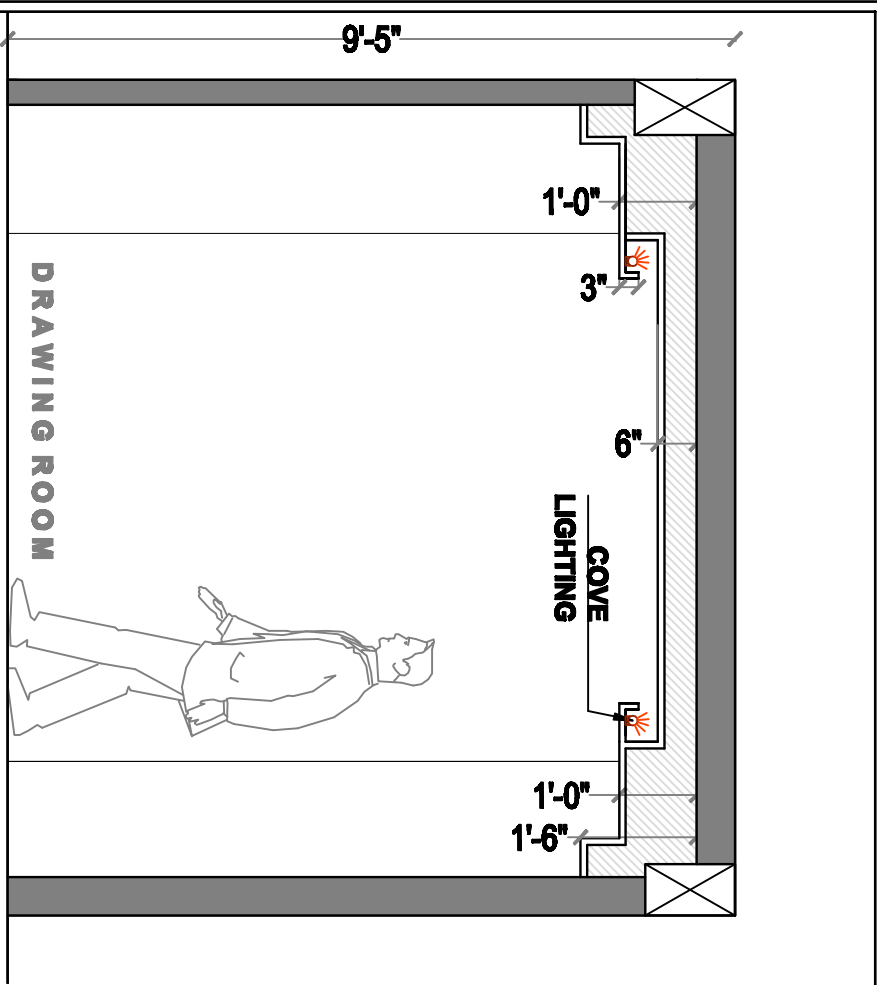


Sec-Elevation_AA

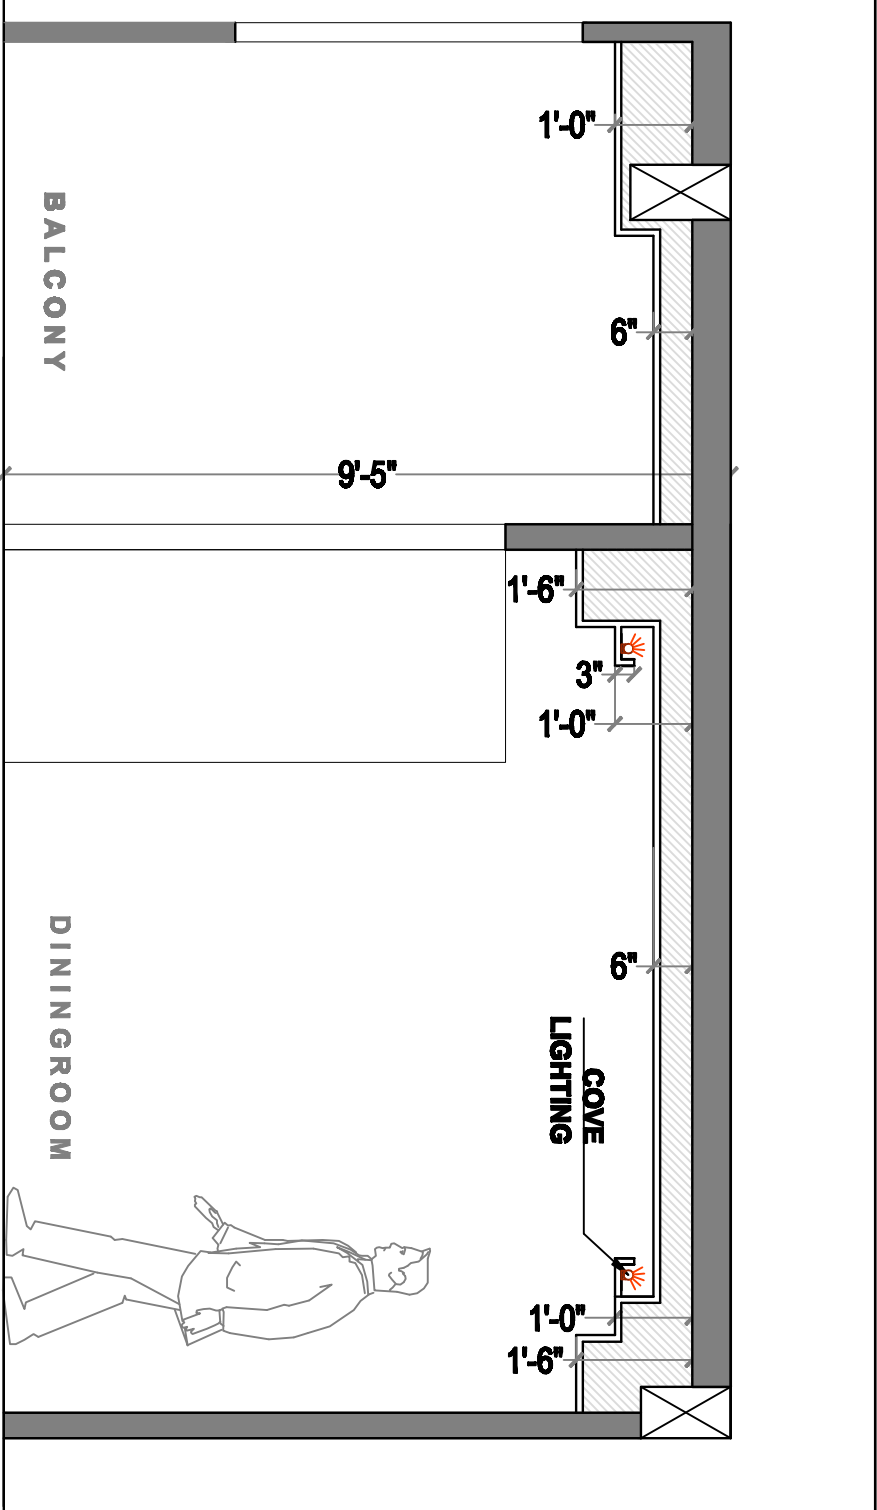

Sec-Elevation_BB

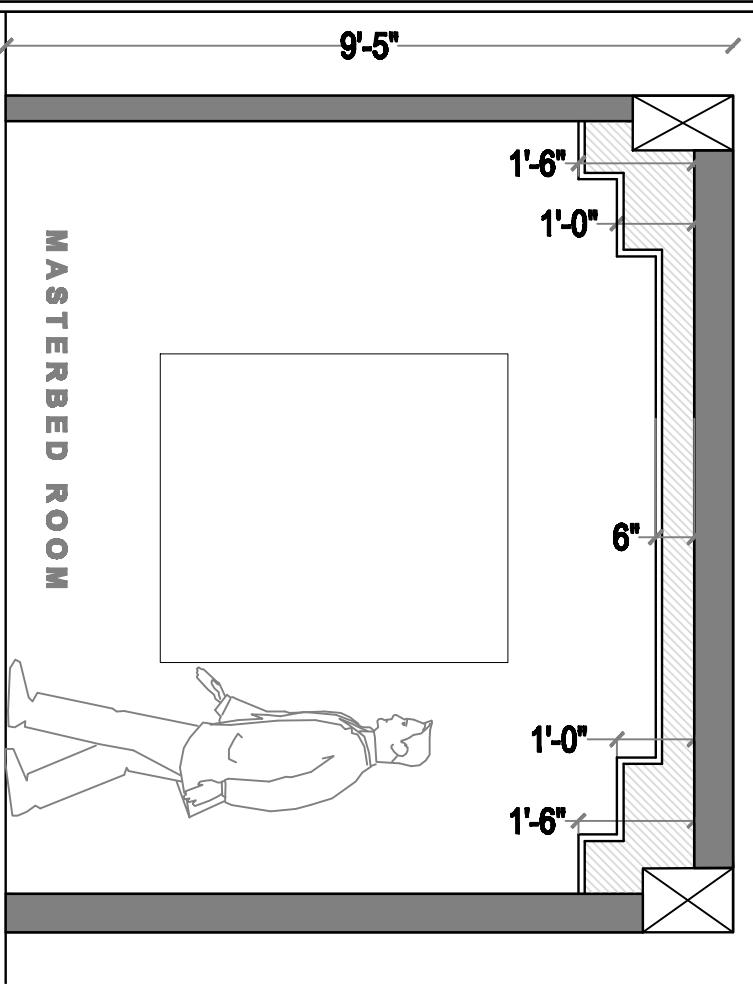

Sec-Elevation_CC

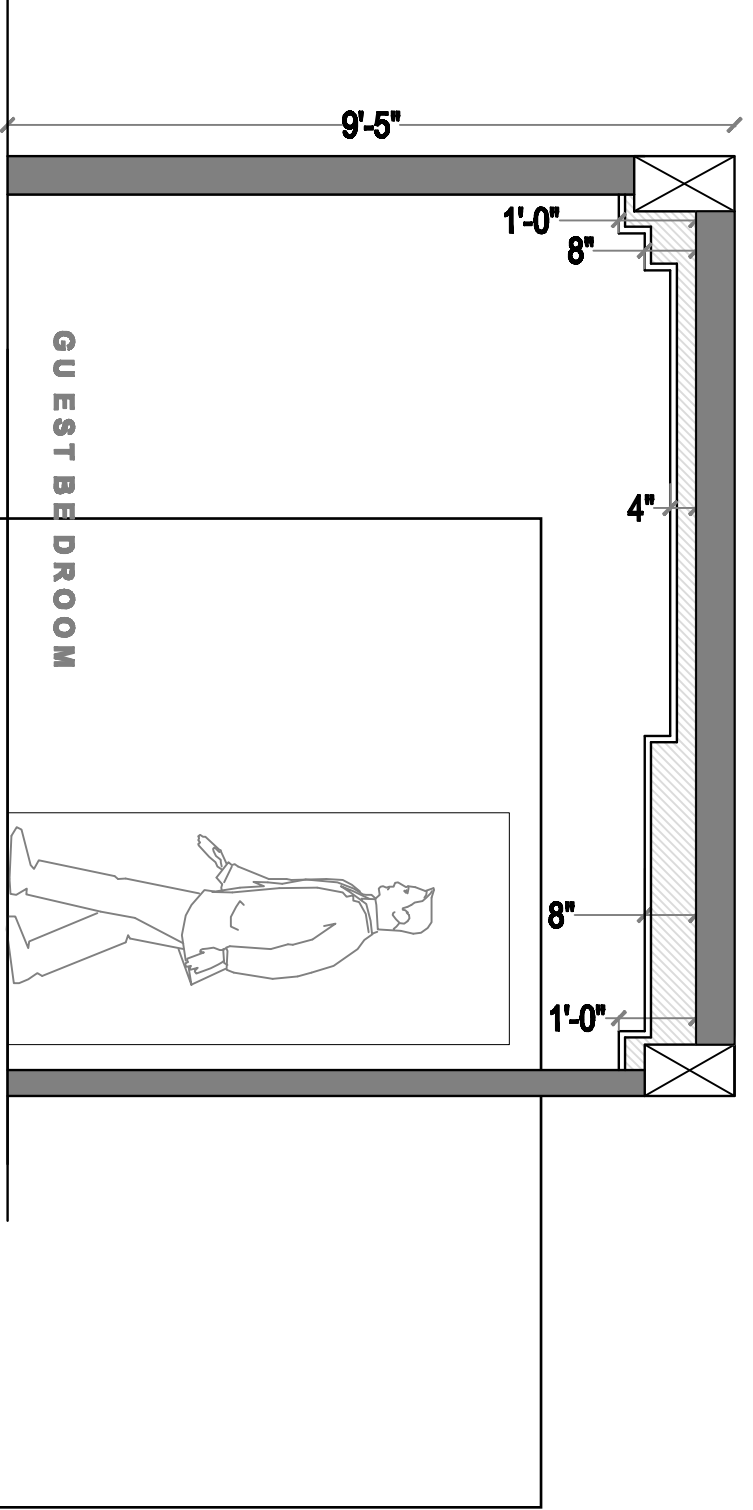

Sec-Elevation_DD

PROJECT			
VISTA HOMES			
MODEL FLAT			
CLIENT			
MODI PROPERTIES			
M.G.ROAD,			
TITLE			
INTERIOR DRAWING			
ELECTRICAL CHANGES			
S.N	DATE	S.N	DATE
DRAWING DETAILS			
2BHK-WEST FACING			
MODEL FLAT-TYPE C-103			
FALSE CEILING SECTIONS			
Scale:			
Drawn by: AM			
Checked by: AR			
Date: 10-10-13			
Drawing Codes:			
Sheet No.: 04 OF 04			
INTERIOR CONSULTANTS:			
ARDES			
ARCHITECTS & INTERIOR DESIGNERS			
7-1-21234NVAAGH, AMBERPET, HYDERABAD,			
040-2873331 & email: modidesign@gmail.com			