


Project	SERENE FARM	Flat Villa No:	3 & 4			
Customer Name	T. PRIANKA & T.A.S PRASAD	Request letter date	23-03-2019			
A&A Signed	☐	Yes	☐	A&A date	23-03-2019	
			stage of work	RCC (padestal & Plinth completed)		
Remarks of CR/site						
Sr.NO	Description of A&A request by customer	Addition & alterations permitted as per guidelines	approved by site engg	MDs approval required	At extra cost	Modified plans from HO required
1	The kitchen cross wall to be straight wall with existing window.	YES	YES	YES	YES	YES
2	Common toilets & store room to be remove	YES	YES	YES	NO	YES
3	Master toilets to be divide in to part one for master bedroom (6'x7') and another for children room (6'x4'8").	YES	YES	YES	NO	YES
4	Partition wall between hall & kitchen to be extend up to 8'	YES	YES	YES	NO	YES
Remarks By MD						


Notes: 1. Site engineer may approve or disapprove as per standard guidelines. 2. Request has to be sent by CR / site to Ashaiya only where required. 3. Ashaiya to cut & paste A&A required by customer in this form. 4. Form to be updated by Ashaiya during MDs site visit. 5. Ashaiya to keep printouts in MDs folder for site visits.

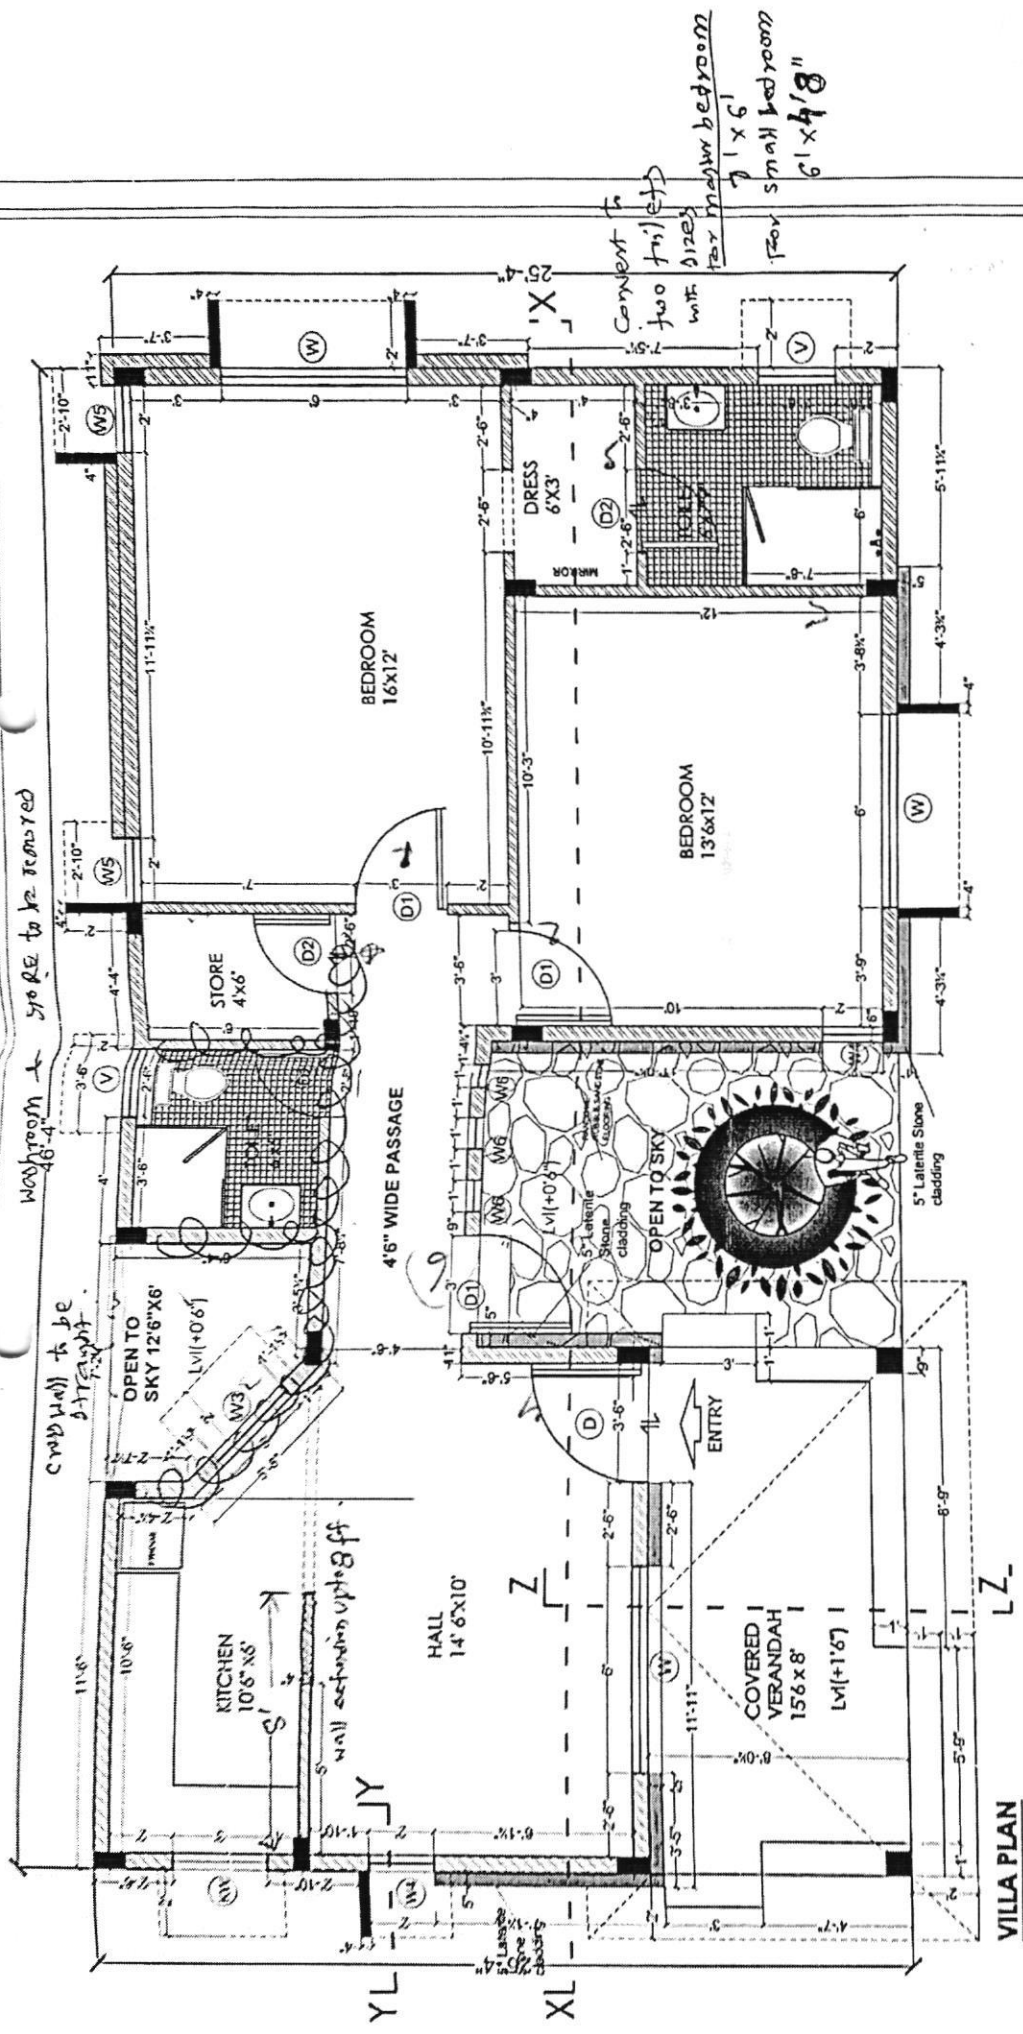

PROJECT			
FARM HOUSES			
YENKAPALLI			
Hyderabad			
CLIENT			
MODI PROPERTIES			
TITLE			
ARCHITECTURE DRAWING			
WORKING DRAWING			
DOORS: D - 3'6" X 7'0" D1 - 3'0" X 7'0" D2 - 2'6" X 7'0" WINDOWS: W - 6'0" X 6'0" W1 - 5'0" X 6'0" W2 - 4'0" X 4'0" W3 - 3'0" X 4'6" KW - 3'0" X 3'6" W4 - 2'X6'-0" W5 - 2'X4'-6" W6 - 1'0" X 7'0" V - 2'6" X 2'0"			
S.No	DATE	S.No	DATE
DRAWING DETAILS			
TYPICAL VILLA PLAN			
Working Drawing			
Scale:			
Drawn by:		AM	
Checked by:		AR	
Date:		30/09/2015; 15/06/15	
Drawing Code:		AR-WRK-VILLA	
Sheet No:			
INTERIOR CONSULTANTS:			
ARDES			
ARCHITECTS & INTERIOR DESIGNERS			
7-1-212, SHIV-BAGH, AMERPET, HYDERABAD.			
040-23753316; email: mailardes@gmail.com			


WALL HANGING WC WITH
CONCEALED FLUSH TANK

COUNTER TOP WASH BASIN

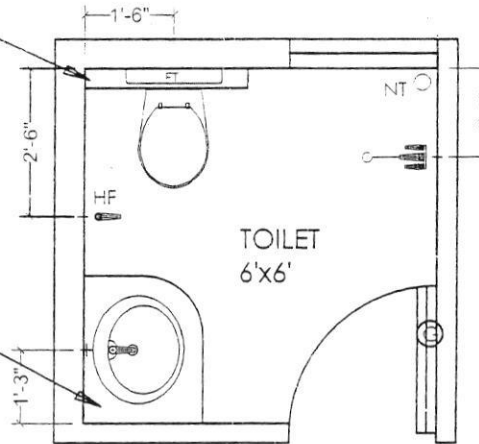


WALL HANGING WC WITH
CONCEALED FLUSH TANK

COUNTER TOP WASH BASIN

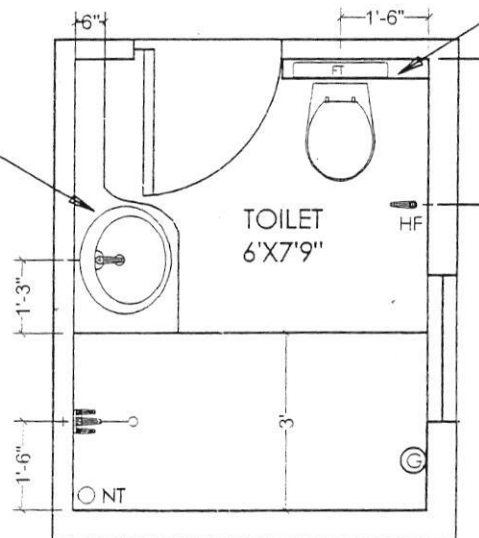

*Approved for
Cont 1.*

Description	Direction	Owners & Developers :	Date :	15.04.2016	Promoted by
VILLA - PLUMBING PLAN		Modi Properties & Investments Pvt.Ltd	Prepared By :		Modi Properties &
		Project Name & Phase :	Approved By :	Soham Modi	Investments Pvt. Ltd.
		SERENE FARMS	Scale :	N.T.S	Phone:+91-40-66335551

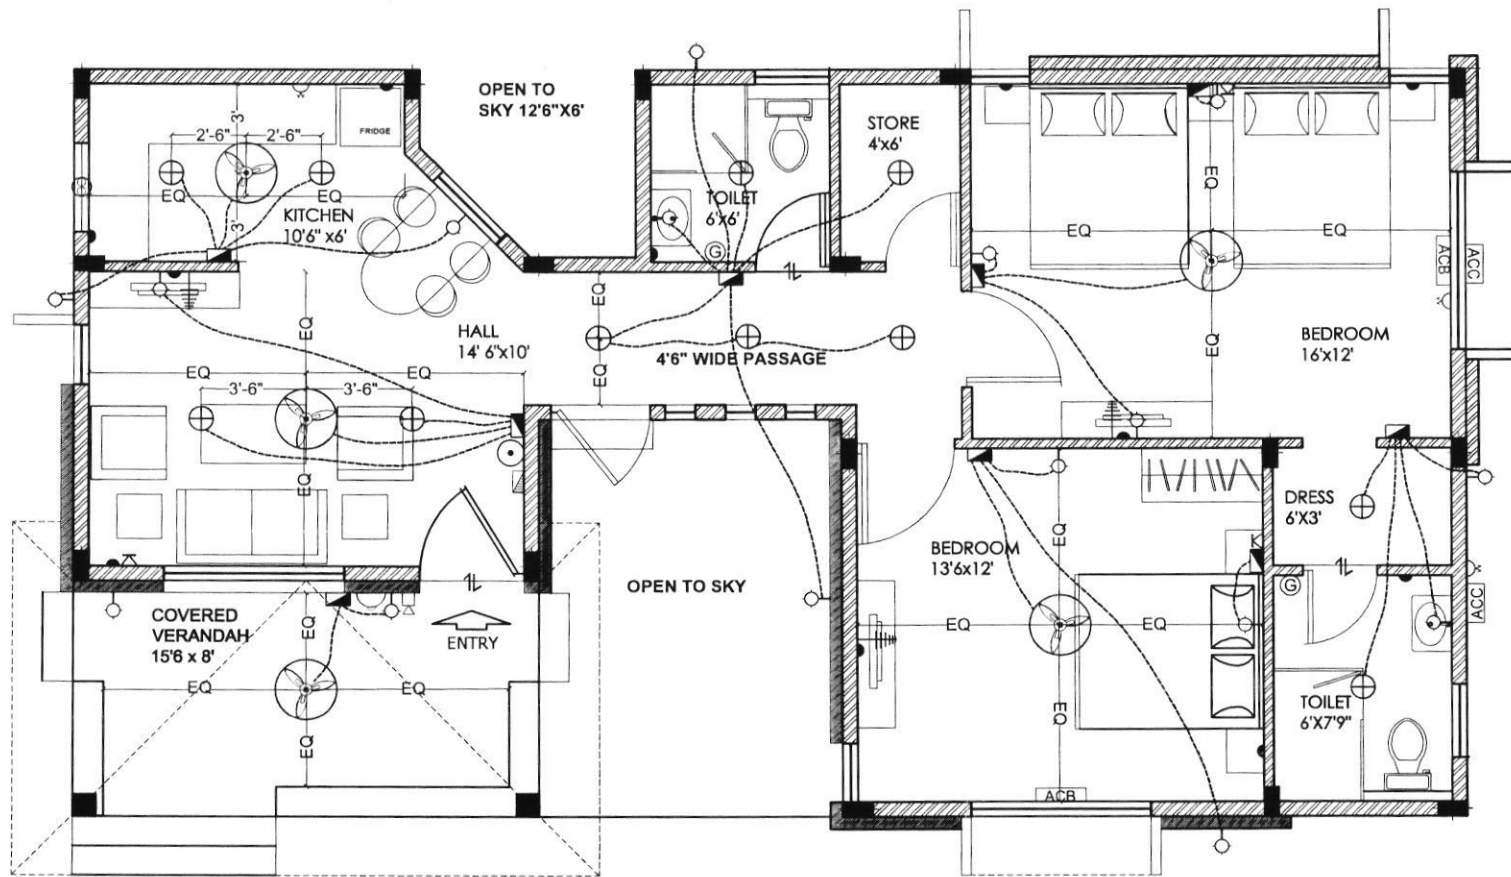

LEGEND:-

S.NO	ITEM	SYMBOL
1.	Distribution Board & Change over	
2.	Switch board	
3.	Wall point/Bracket light	
4.	5 amps plug point	
5.	Ceiling fan	
6.	Geyser point - 15A	
7.	Exhaust fan	
8.	15 amps plug point	
9.	Television point	
10.	Telephone point	
11.	Calling Bell	
12.	Bell Push	
13.	Ceiling light	
14.	Video Phone	
15.	AC Compressor	
16.	AC Blower	
17.	Switch board with 5A socket	

Note :- Switch boards next to bed side must be centered @ 3'6" center of bed.

VILLA PLAN

Description	Direction	Owners & Developers :	Date :	09.12.15	Promoted by
ELECTRICAL PLAN OF VILLA		Modi Properties & Investment Pvt Ltd.	Prepared By :	M.Nagalaxmi	Modi Properties & Investments Pvt. Ltd. Phone:+91-40-66335551
		Project Name & Phase :	Approved By :	Soham Modi	
		SERENE FARMS	Scale :	N.T.S	